




LEGEND




MUSTER STATION - DESIGNATED EMERGENCY ASSEMBLY AREA




CAFETERIA OR FOOD SERVICE



SMOKING AREA



EMERGENCY PHONE

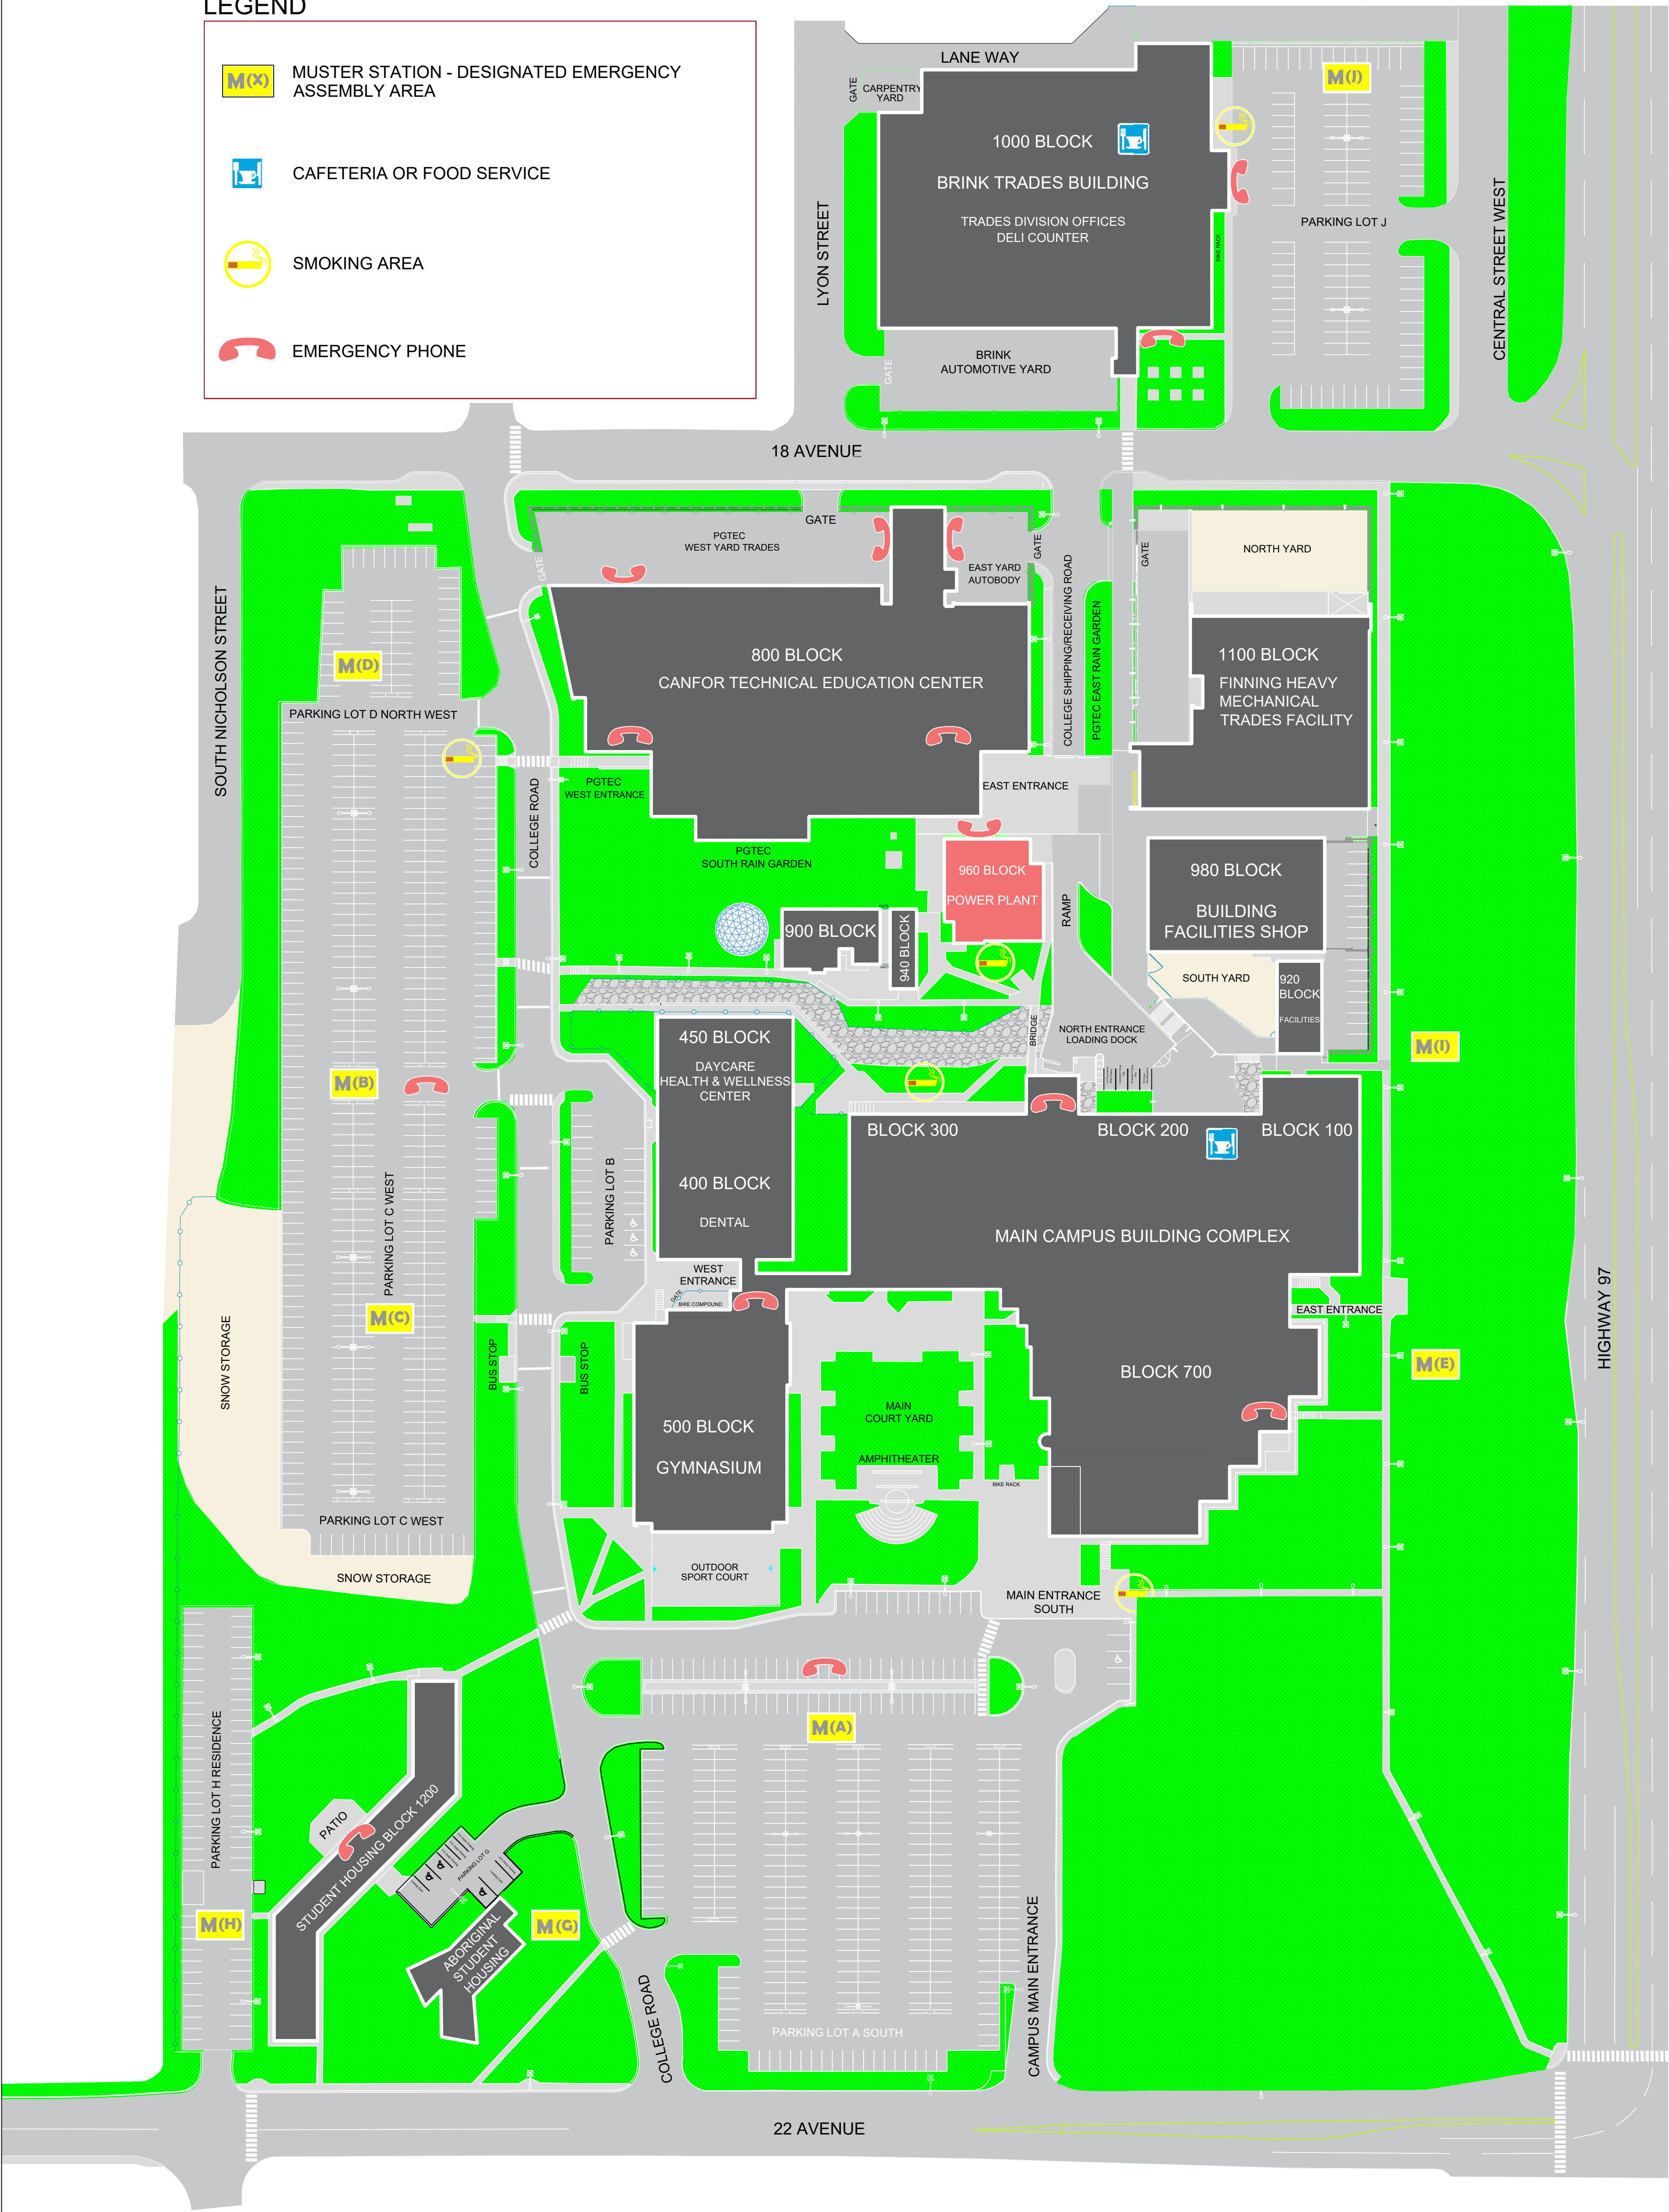

College of New Caledonia

Facility Services, Room 2-332, 3330 - 22nd Avenue, Prince George, British Columbia
Tel (250) 561-5821, Fax (250) 561-5865, Web www.cnc.bc.ca

PROJECT: COLLEGE OF NEW CALEDONIA IN PRINCE GEORGE			
DWG. TITLE: CAMPUS SITE PLAN			
DR. BY:	ROOM NO:	REVISION NO:	REVISION TITLE:
NO.:	SCALE:	REVISION NO:	REVISION TITLE:
DATE: OCT, 2023	SHEET: OF:	REVISION NO:	REVISION TITLE:
LOCATION: PRINCE GEORGE, BRITISH COLUMBIA			

SHEET NO.