


 
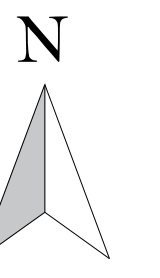


KEY PLAN



LEGEND

	MUSTER STATION DESIGNATED EMERGENCY ASSEMBLY AREA
	AUTOMATED EXTERNAL DEFIBRILLATOR
	SMOKING AREA

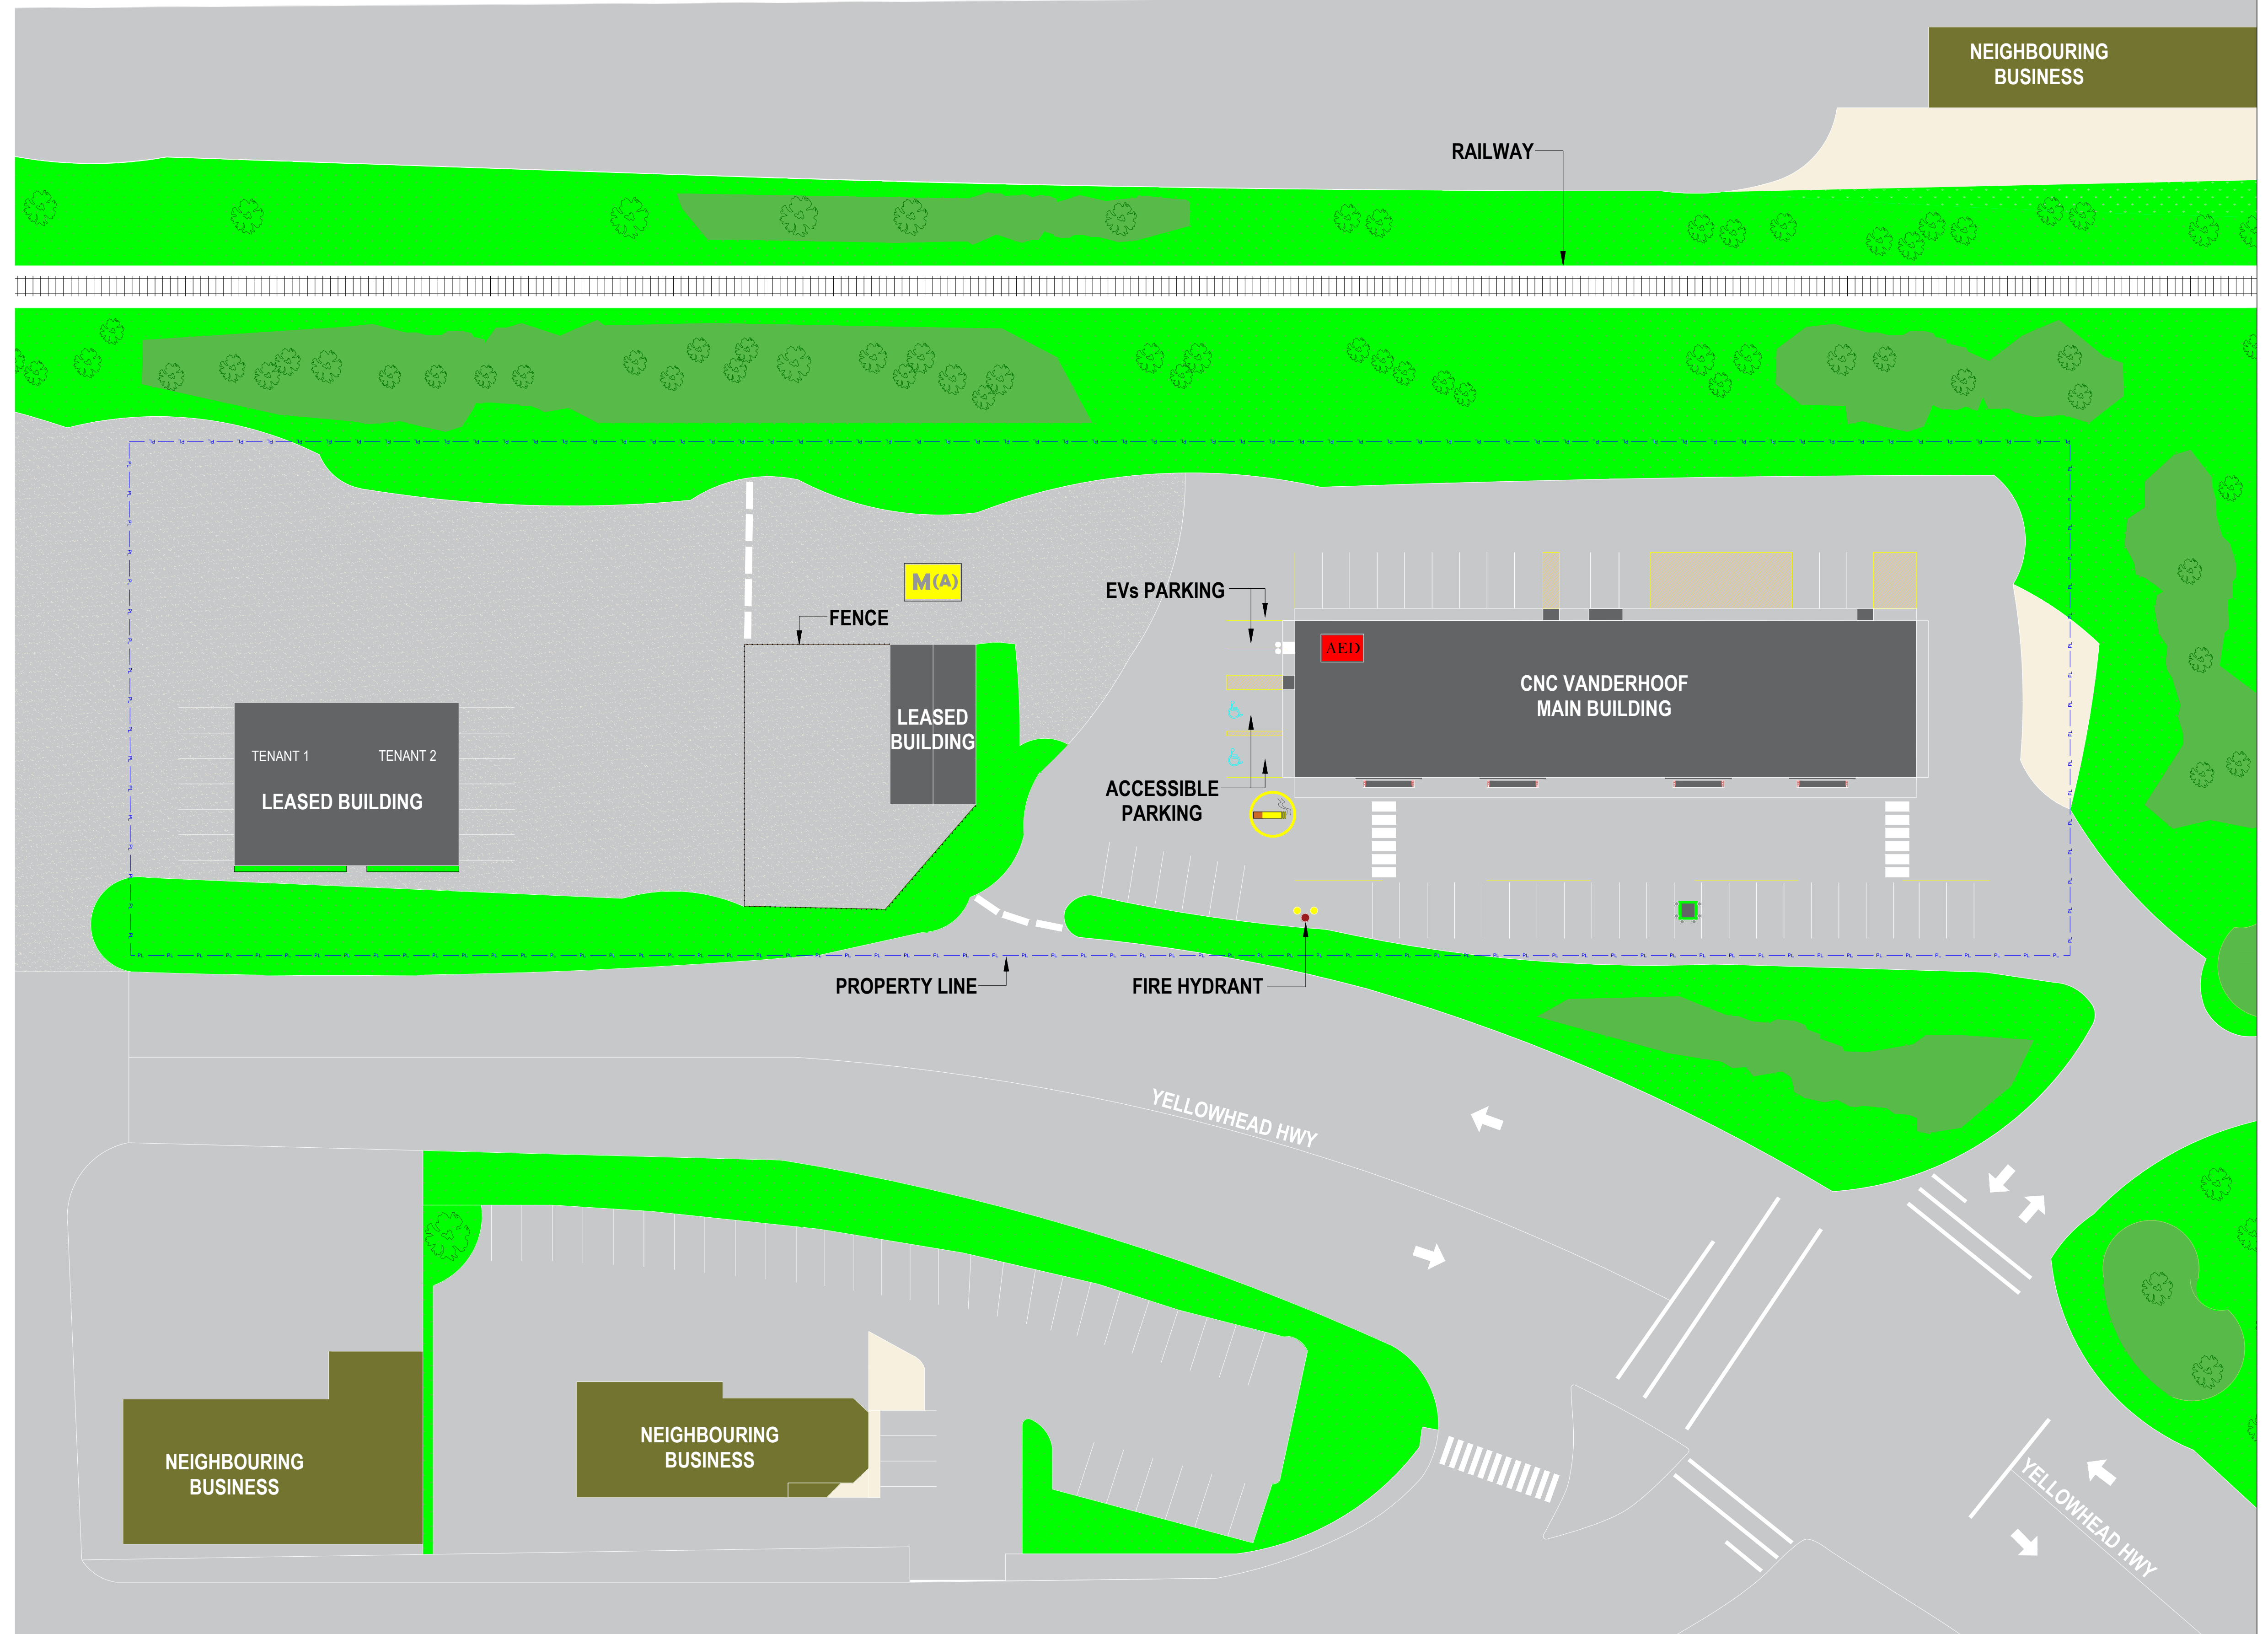


**College of New Caledonia**

Facility Services, Room 2-332, 3330 - 22nd Avenue, Prince George, British Columbia  
Tel (250) 561-5821, Fax (250) 561-5865, Web www.cnc.bc.ca

PROJECT: CNC VANDERHOOF CAMPUS			
DWG. TITLE: SITE PLAN			
DR. BY:	ROOM NO.:	REVISION NO.:	REVISION TITLE:
NO.:	SCALE:	REVISION NO.:	REVISION TITLE:
DATE: JULY 2024	SHEET: OF:	REVISION NO.:	REVISION TITLE:
LOCATION: VANDERHOOF, BRITISH COLUMBIA			

SHEET NO.

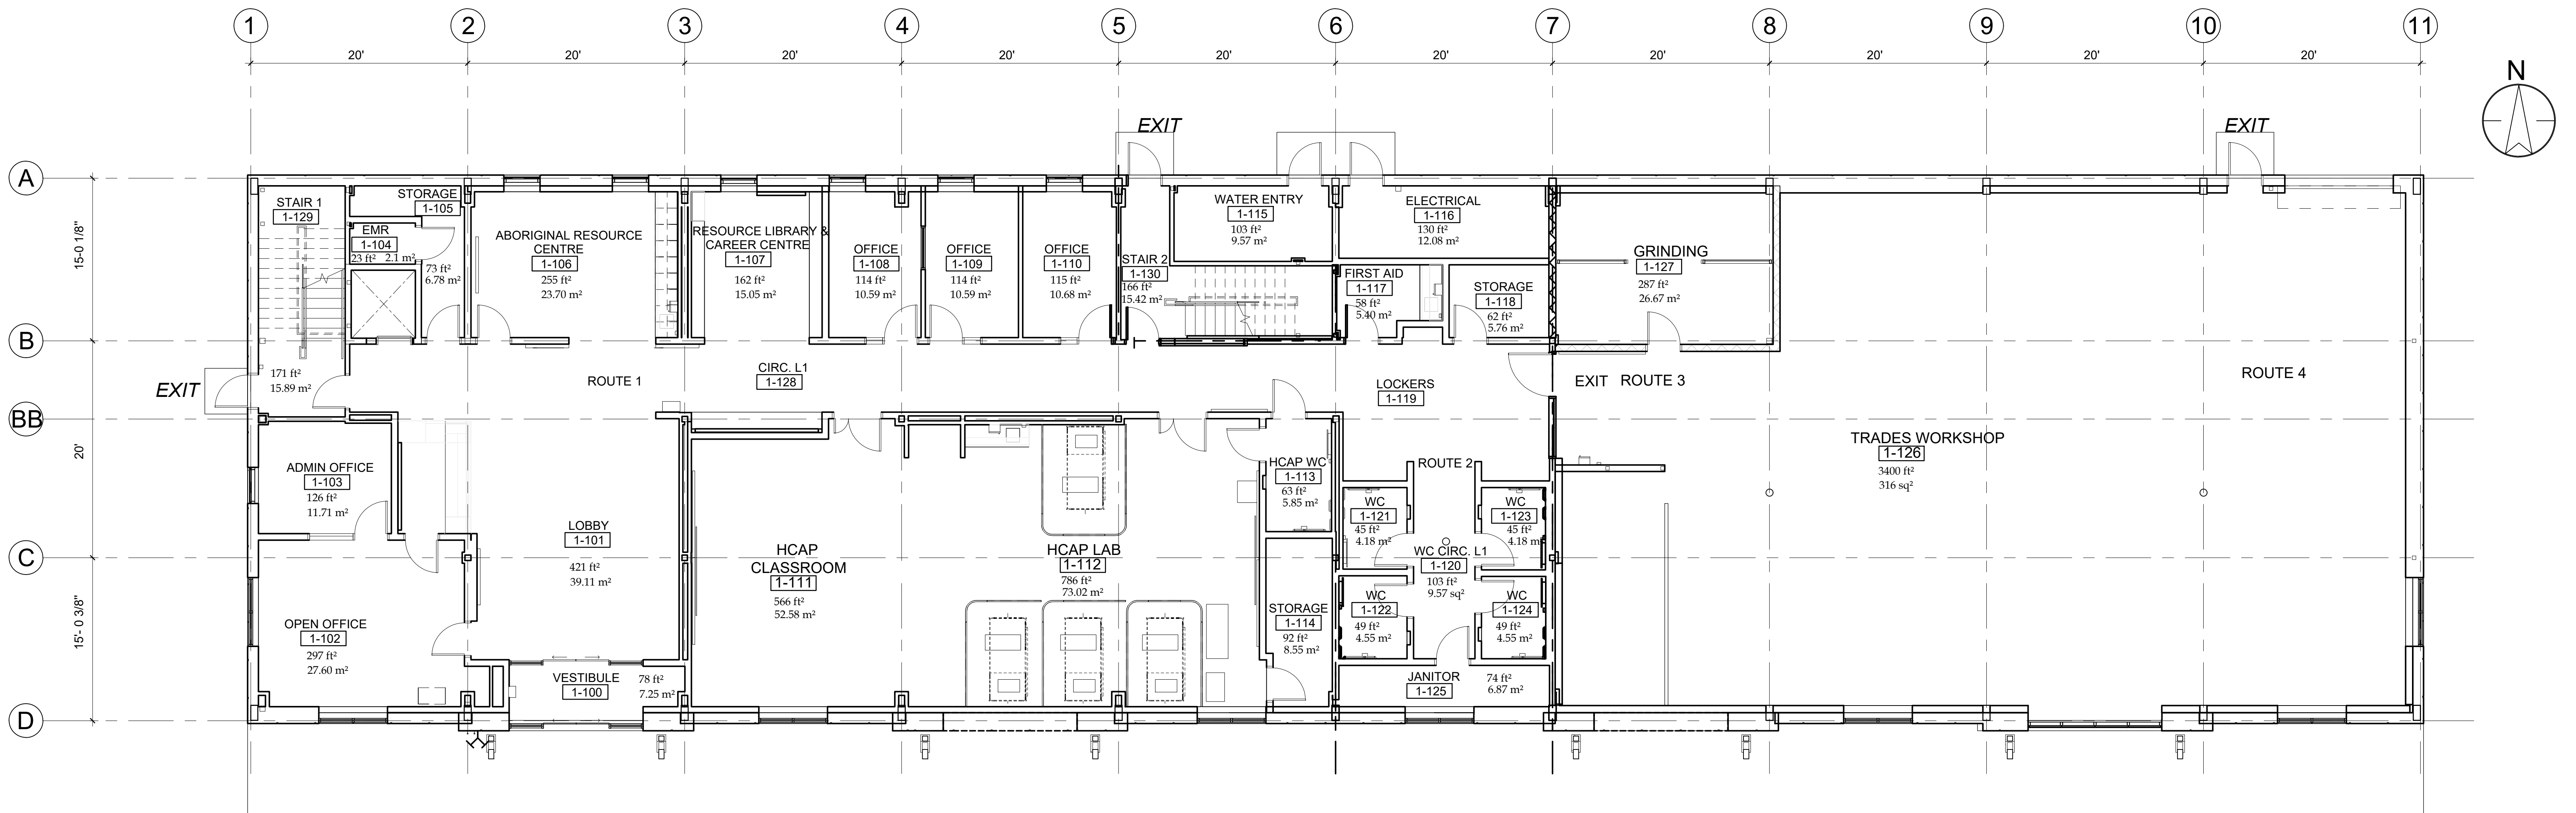

**1 FLOOR PLAN LEVEL 1**  
A01 NTS




**College of New Caledonia**  
 Facility Services, Room 2-332, 3330 - 22nd Avenue, Prince George, British Columbia  
 Tel (250) 561-5821, Fax (250) 561-5865, Web www.cnc.bc.ca

PROJECT: COLLEGE OF NEW CALEDONIA IN VANDERHOOF			
DWG. TITLE: VANDERHOOF NEW BUILDING - FLOOR PLAN LEVEL 1			
DR. BY:	ROOM NO.:	REVISION NO.:	REVISION TITLE:
NO.:	SCALE: NTS	REVISION NO.:	REVISION TITLE:
DATE: OCT, 2023	SHEET: 1 OF: 2	REVISION NO.:	REVISION TITLE:
LOCATION: PRINCE GEORGE, BRITISH COLUMBIA			

Note:

SHEET NO. **A-01**

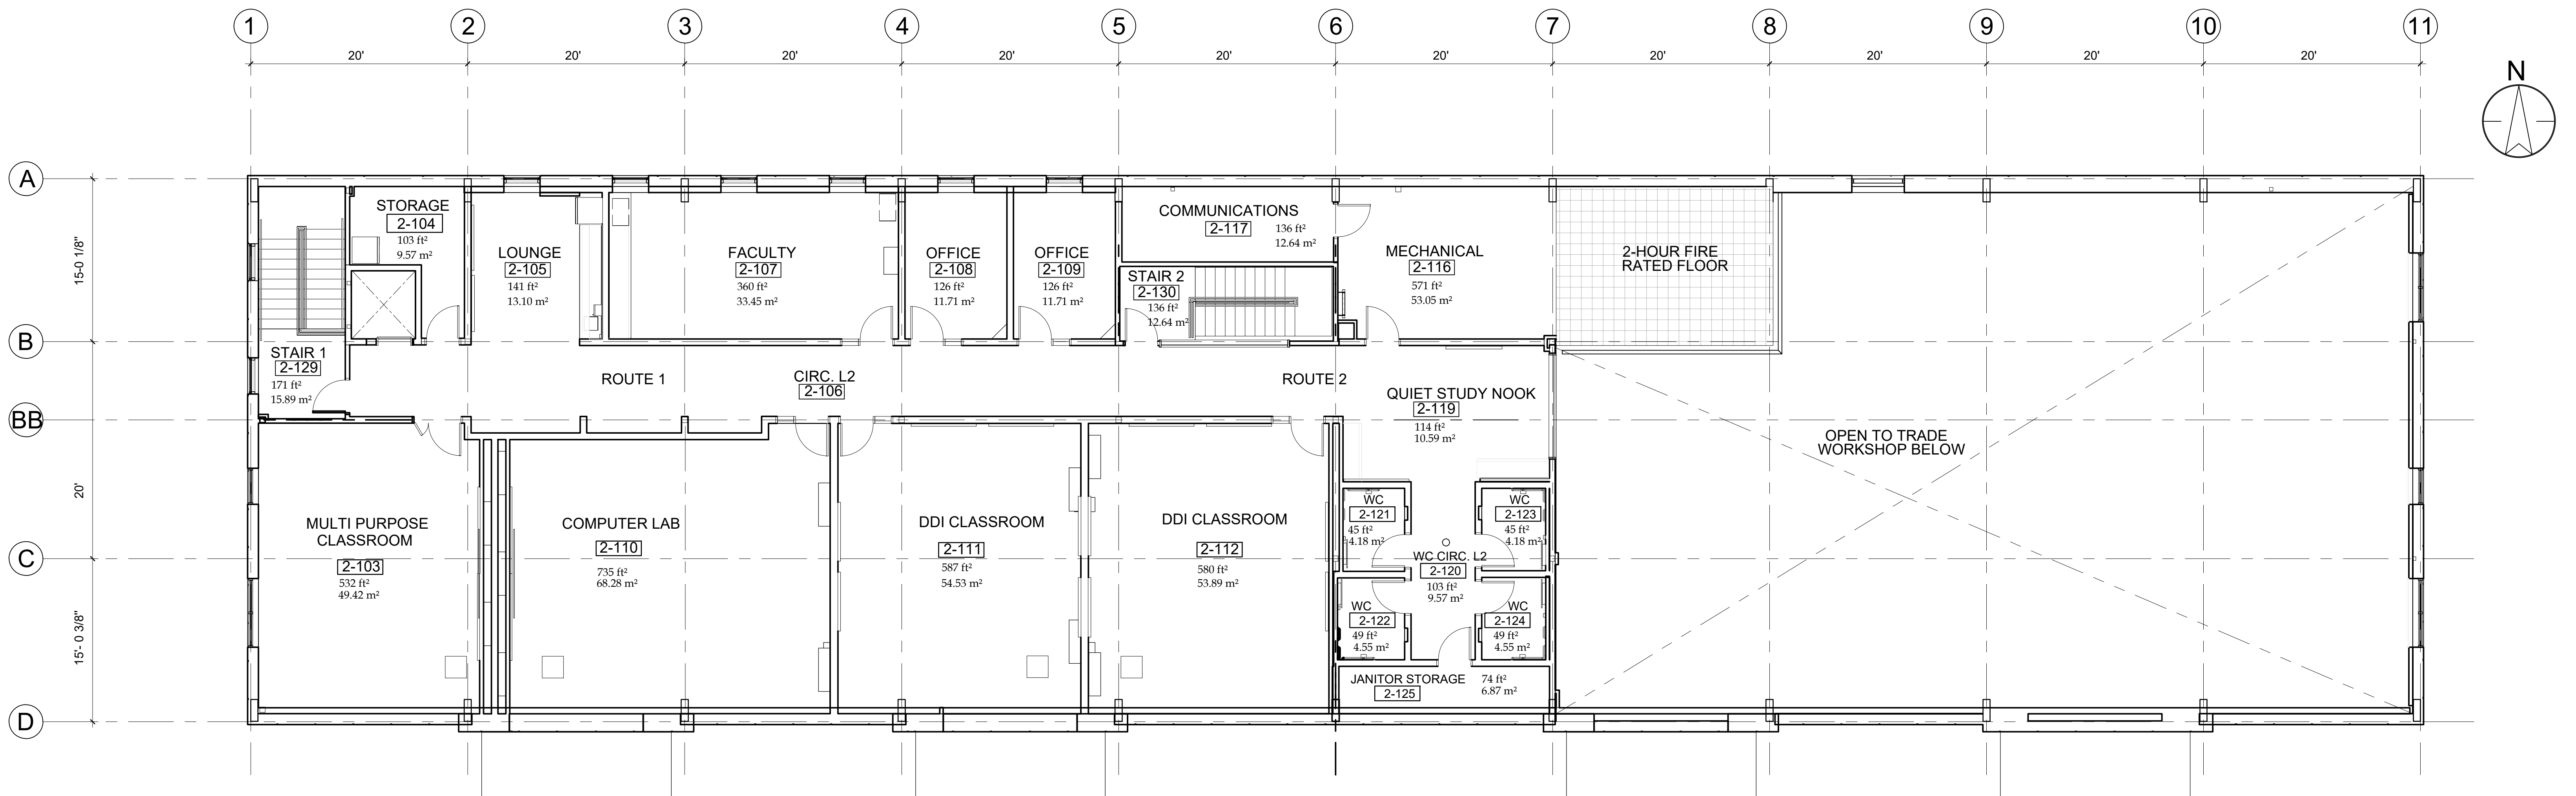

**1 FLOOR PLAN LEVEL 2**  
A02 NTS



**College of New Caledonia**  
 Facility Services, Room 2-332, 3330 - 22nd Avenue, Prince George, British Columbia  
 Tel (250) 561-5821, Fax (250) 561-5865, Web www.cnc.bc.ca

PROJECT: COLLEGE OF NEW CALEDONIA IN VANDERHOOF			
DWG. TITLE: VANDERHOOF NEW BUILDING - FLOOR PLAN LEVEL 2			
DR. BY:	ROOM NO.:	REVISION NO.:	REVISION TITLE:
NO.:	SCALE: NTS	REVISION NO.:	REVISION TITLE:
DATE: OCT, 2023	SHEET: 2 OF: 2	REVISION NO.:	REVISION TITLE:
LOCATION: PRINCE GEORGE, BRITISH COLUMBIA			

Note:

SHEET NO.  
**A-02**